


L&V ARCHITECTS
 1514 17th Street, Suite 207
 Santa Monica, CA 90404
 Tel. (310) 829 0996; Fax. (310) 829 7889

ABRARI + ASSOCIATES
 ELECTRICAL ENGINEERS
 1618 BEN LOMOND DR.
 GLENDALE, CA 91202
 TEL. 818.507.0088 FAX 818.241.4866
 CEL. 818.497.0330
 MAIL@ABRARI.COM




DEVELOPER
MR. ALI MADANI & MR. HOSSEIN ASHTIANI
 1327 EUCLID ST.,
 SANTA MONICA, CA 90404

PROJECT
5 UNIT CONDOMINIUMS
 1327 EUCLID ST.,
 SANTA MONICA, CA 90404

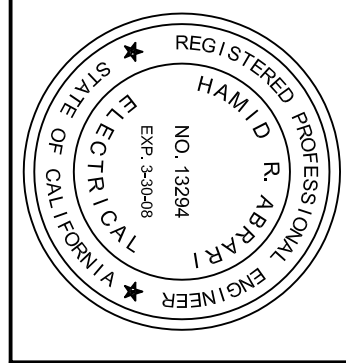

SHEET TITLE
GARAGE ELECTRICAL PLAN
PROJECT NO.: 6-582
SCALE: 1/4"=1'-0"
DATE: 11-01-2006
BY: BB
CHECKED: HRA
DRAWING NO.:
E-4.0

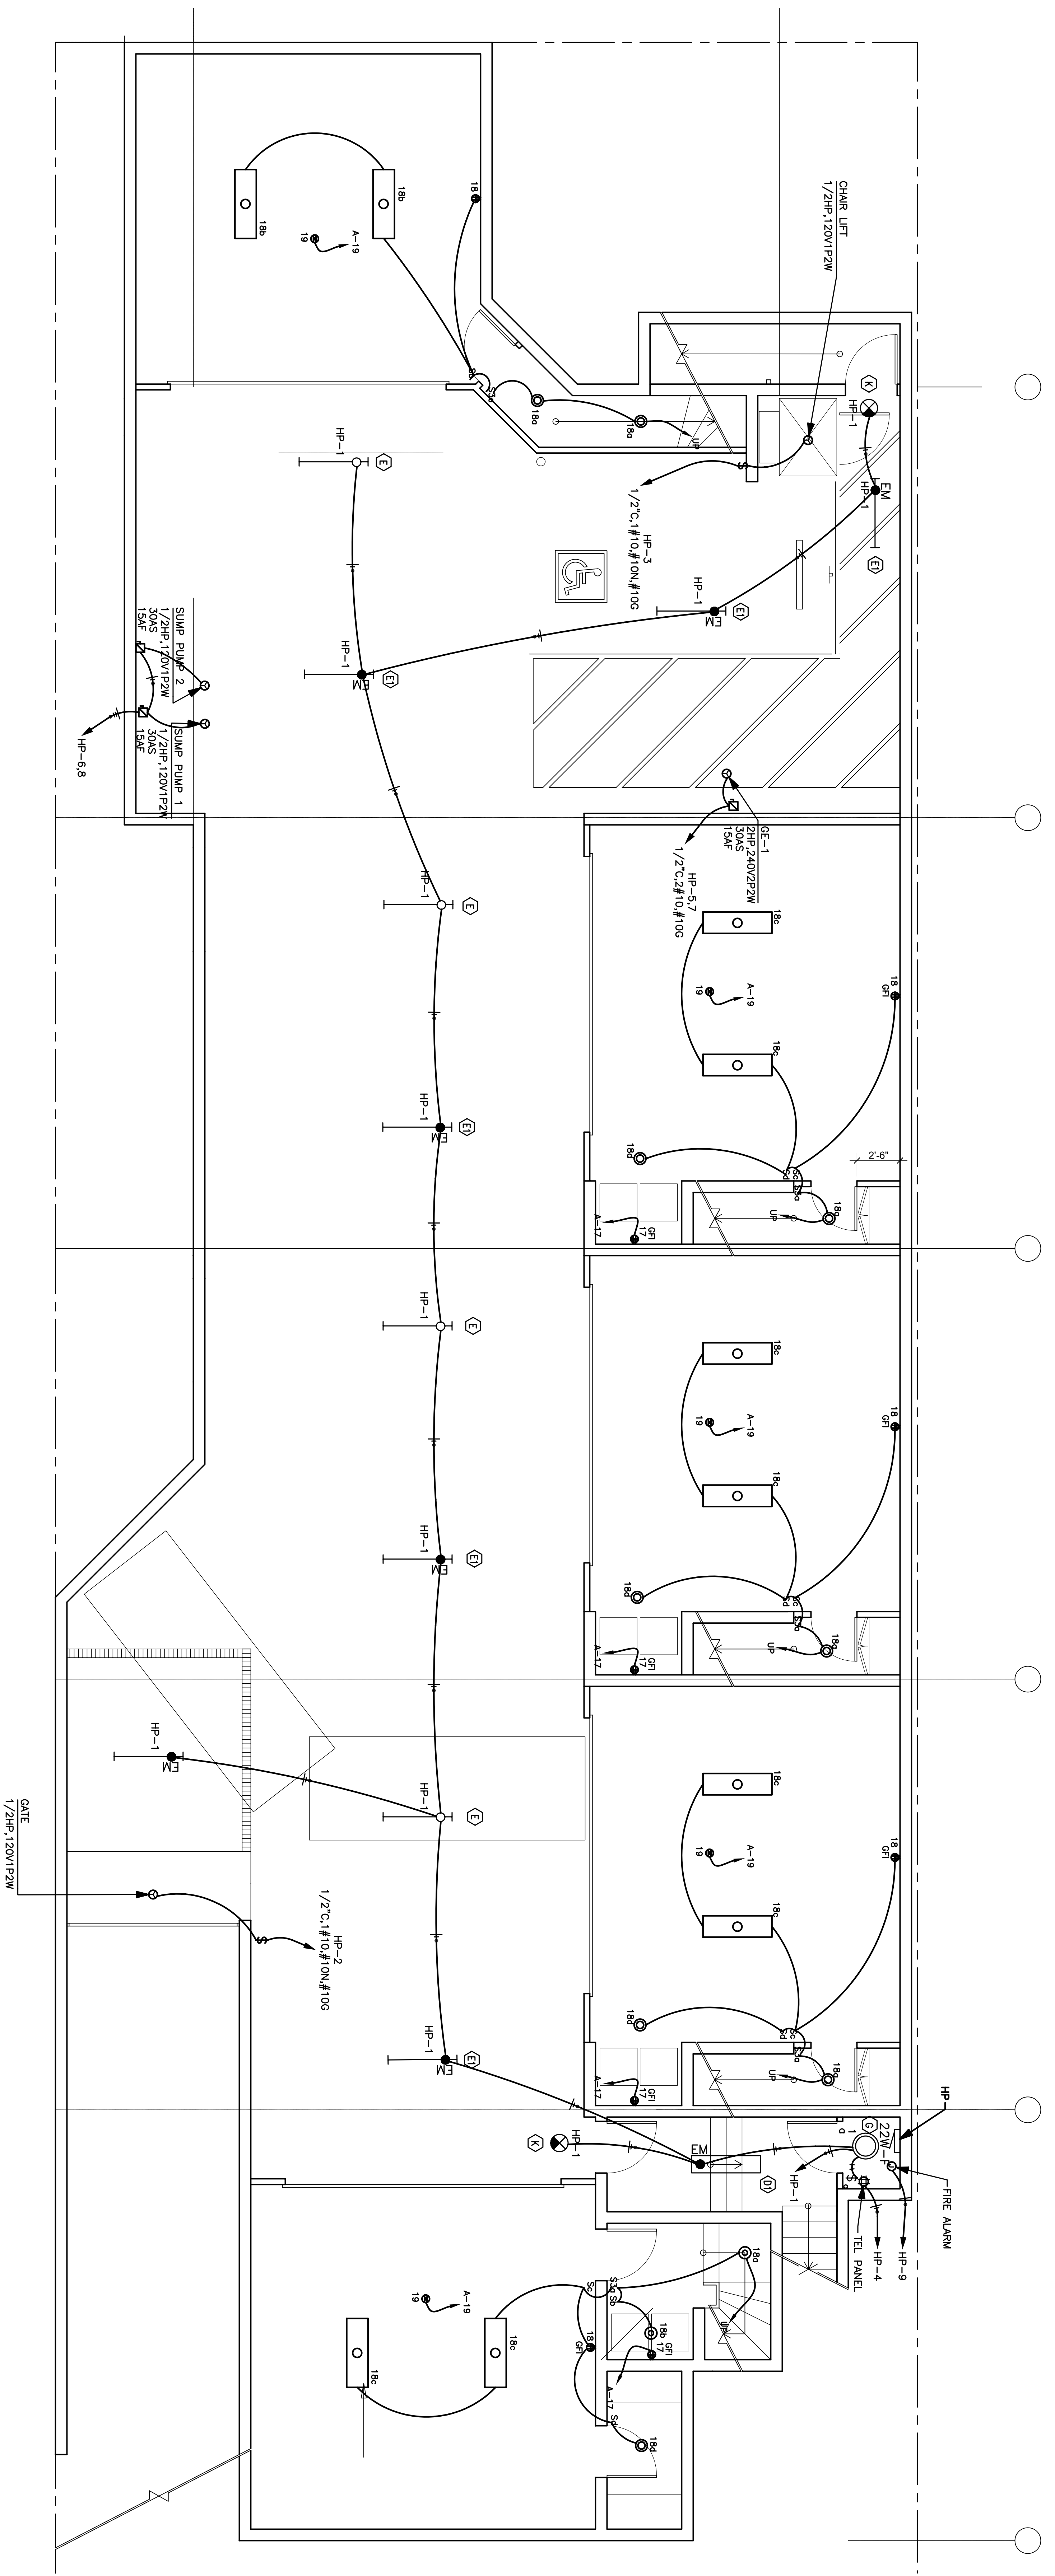

ALL DESIGN, DIMENSIONS AND PLANS INDICATED OR REPRESENTED BY THIS DRAWING ARE OWNED BY ABRARI AND ASSOCIATES AND WERE CREATED IN CONNECTION WITH THE SPECIFIED PROJECT. NONE OF THE DESIGN, DIMENSIONS OR PLANS SHALL BE USED FOR ANY PURPOSE WHATSOEVER WITHOUT THE WRITTEN AUTHORIZATION OF ABRARI AND ASSOCIATES INC.